


VERIFY SCALE
 BAR IS ONE INCH ON ORIGINAL DRAWING
 IF NOT ONE INCH ON THIS SHEET, ADJUST SCALES ACCORDINGLY

SCALE:	AS NOTED	CHK BY:	JRH	DRW BY:	ELL	REF:
DATE:						
REVISION:						
DESCRIPTION:						


HARBOR CONSULTING ENGINEERS
 ENGINEERS • PLANNERS • SURVEYORS
 3006 FUHRMAN AVENUE EAST
 SEATTLE WASHINGTON 98102
 PHONE: (206) 709-2397

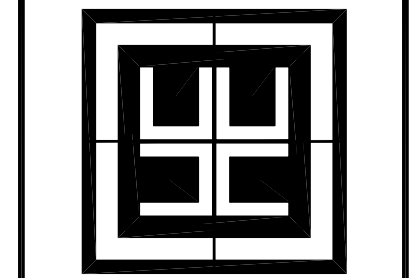


LYLE FALLS FISHWAY IMPROVEMENTS
YAKAMA NATION, TOPPENISH WASHINGTON

INTAKE STRUCTURE PLANS
 JOB NO. 08032.02
 DATE: 01.05.10
 SHEET: 98 OF XX
 DWG.# S5.0


BID SET NOT FOR CONSTRUCTION

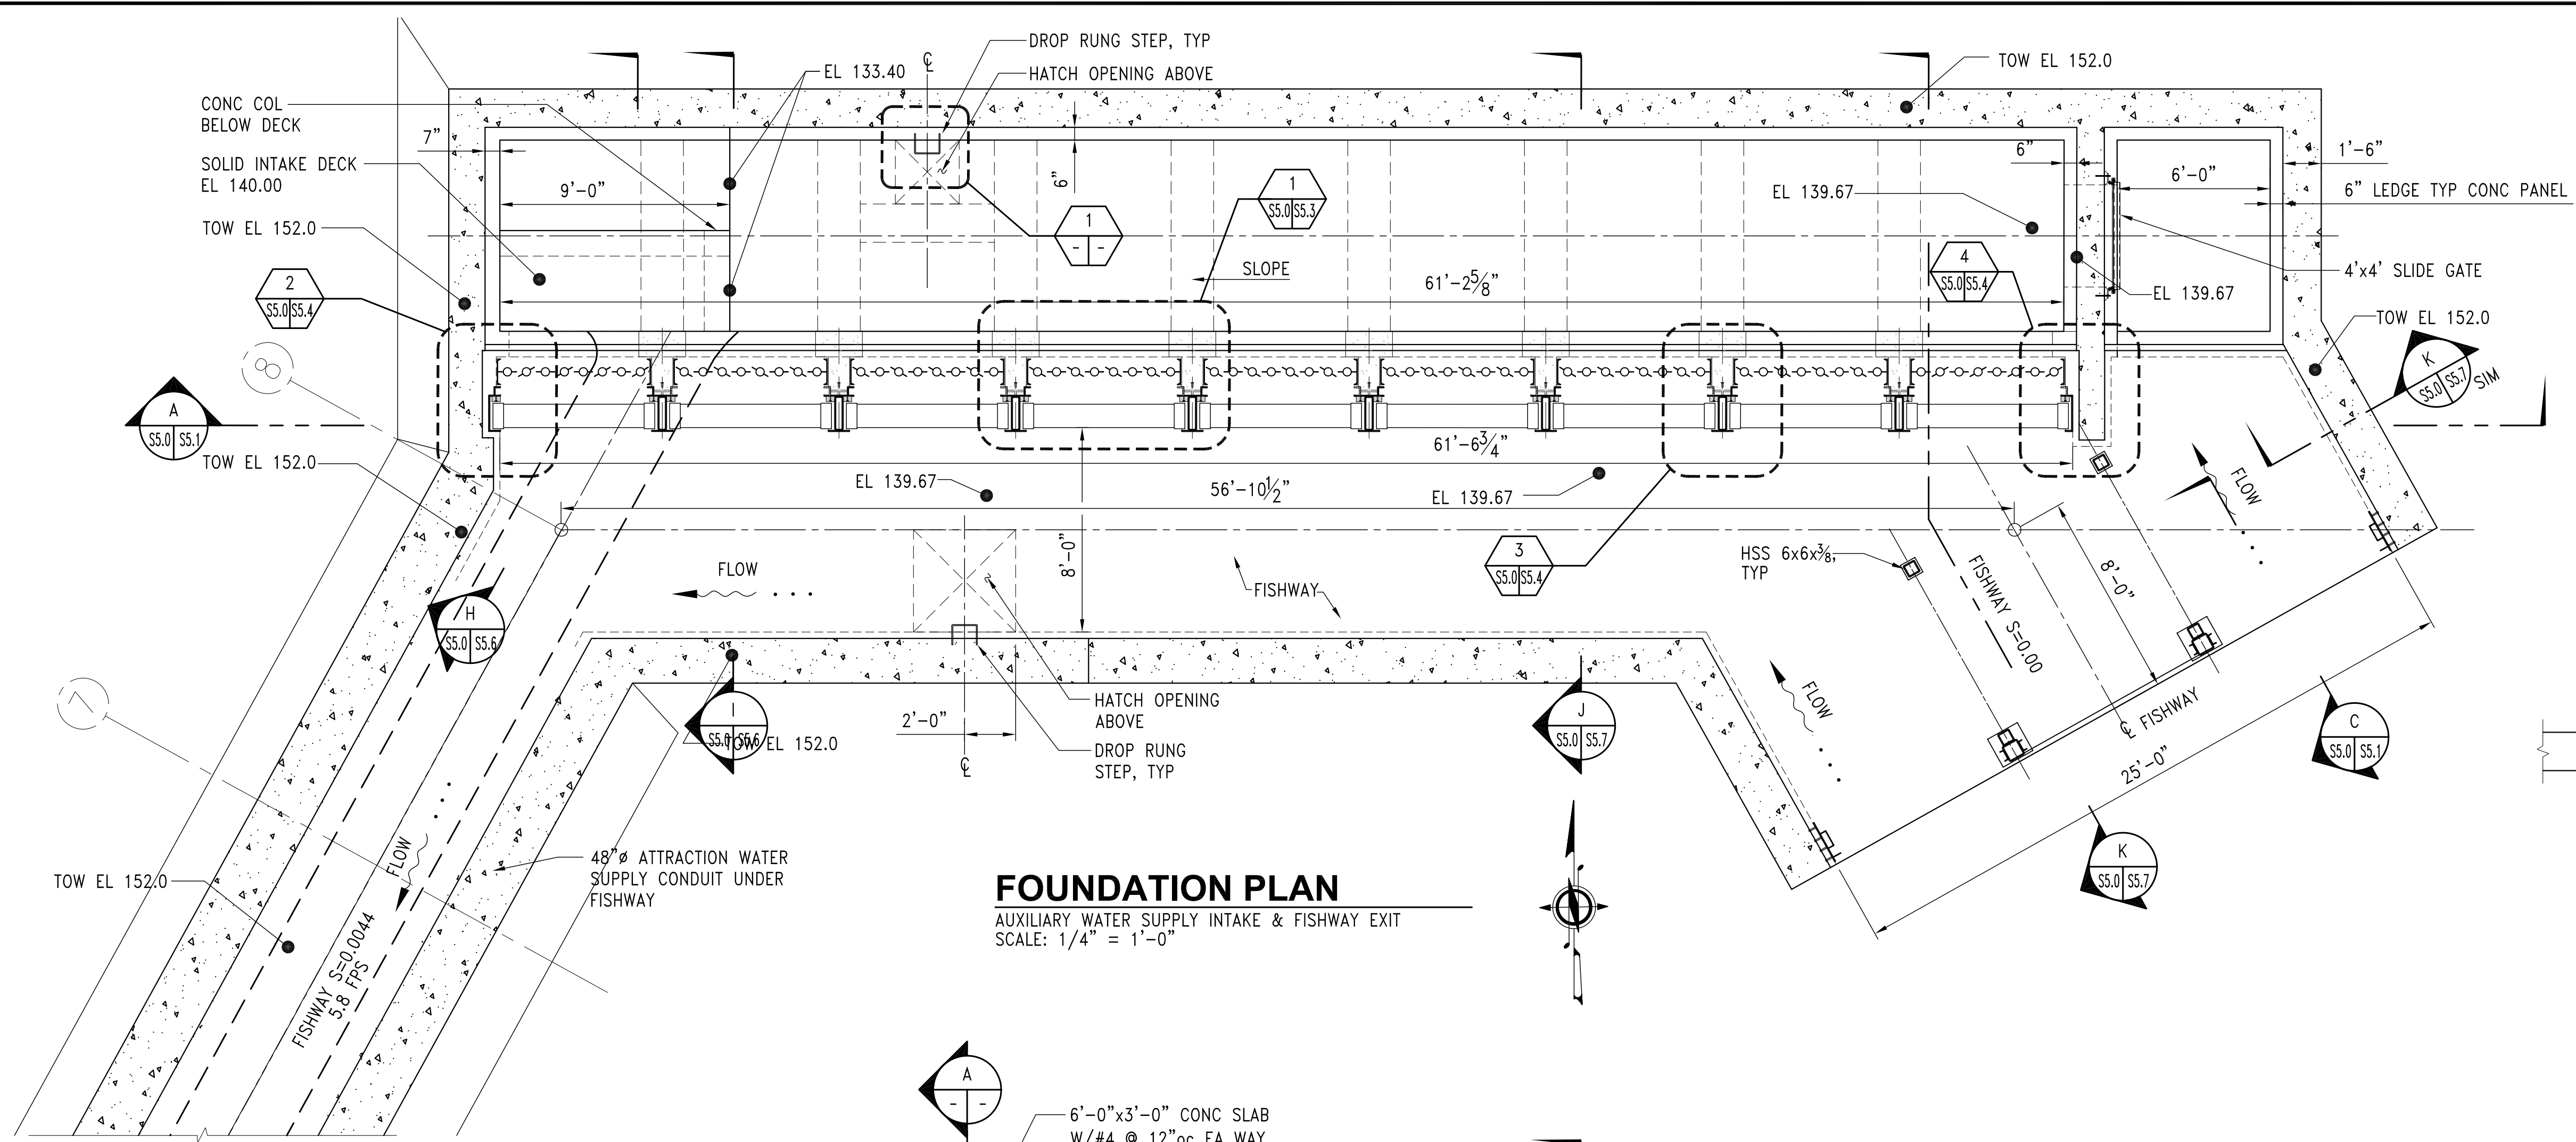


FOUNDATION PLAN
 AUXILIARY WATER SUPPLY INTAKE & FISHWAY EXIT
 SCALE: 1/4" = 1'-0"

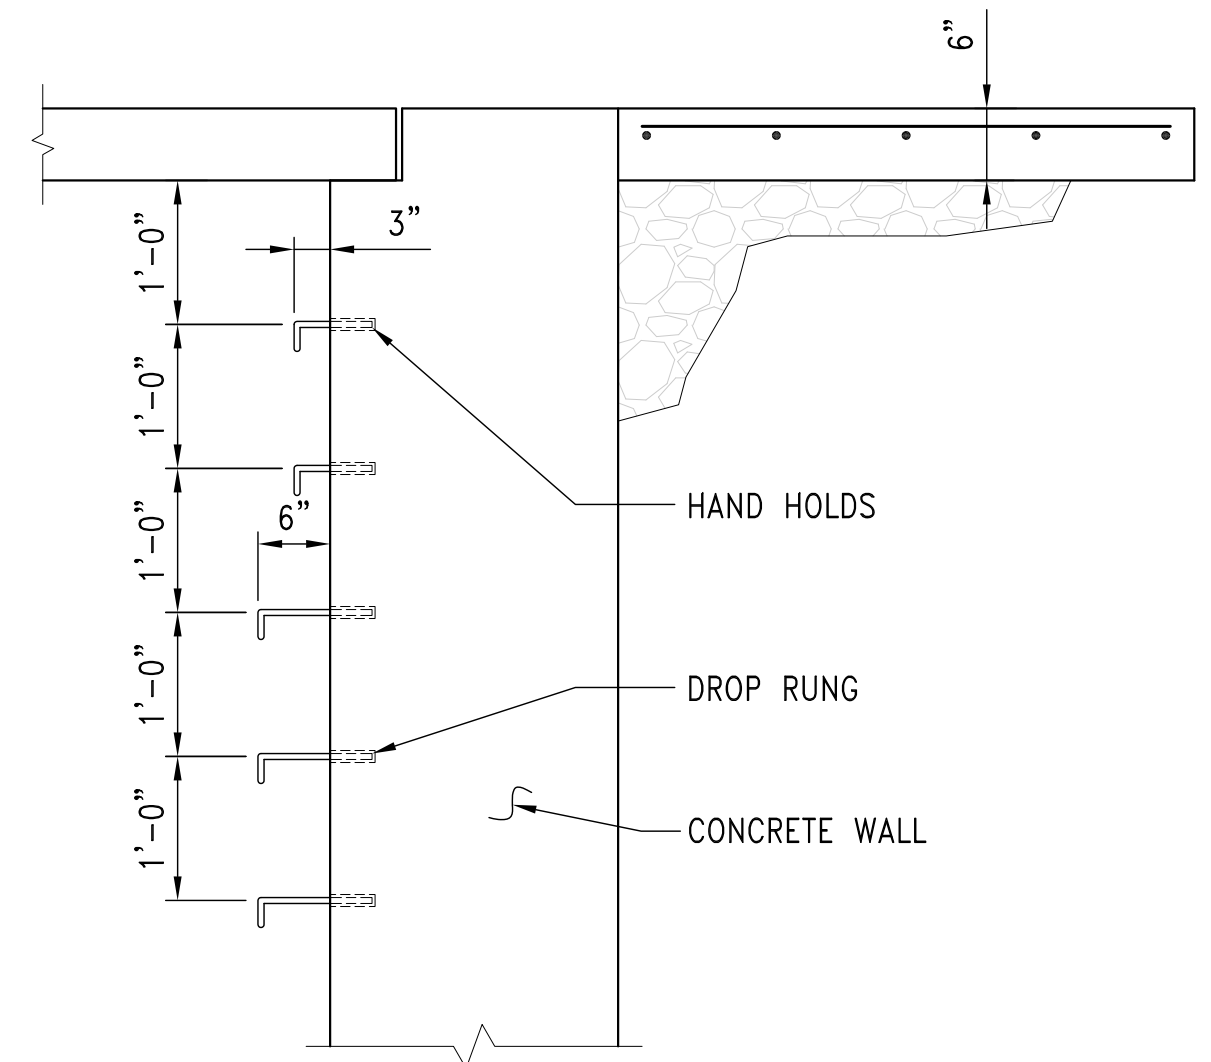


SECTION
 SCALE: 3/4" = 1'-0"

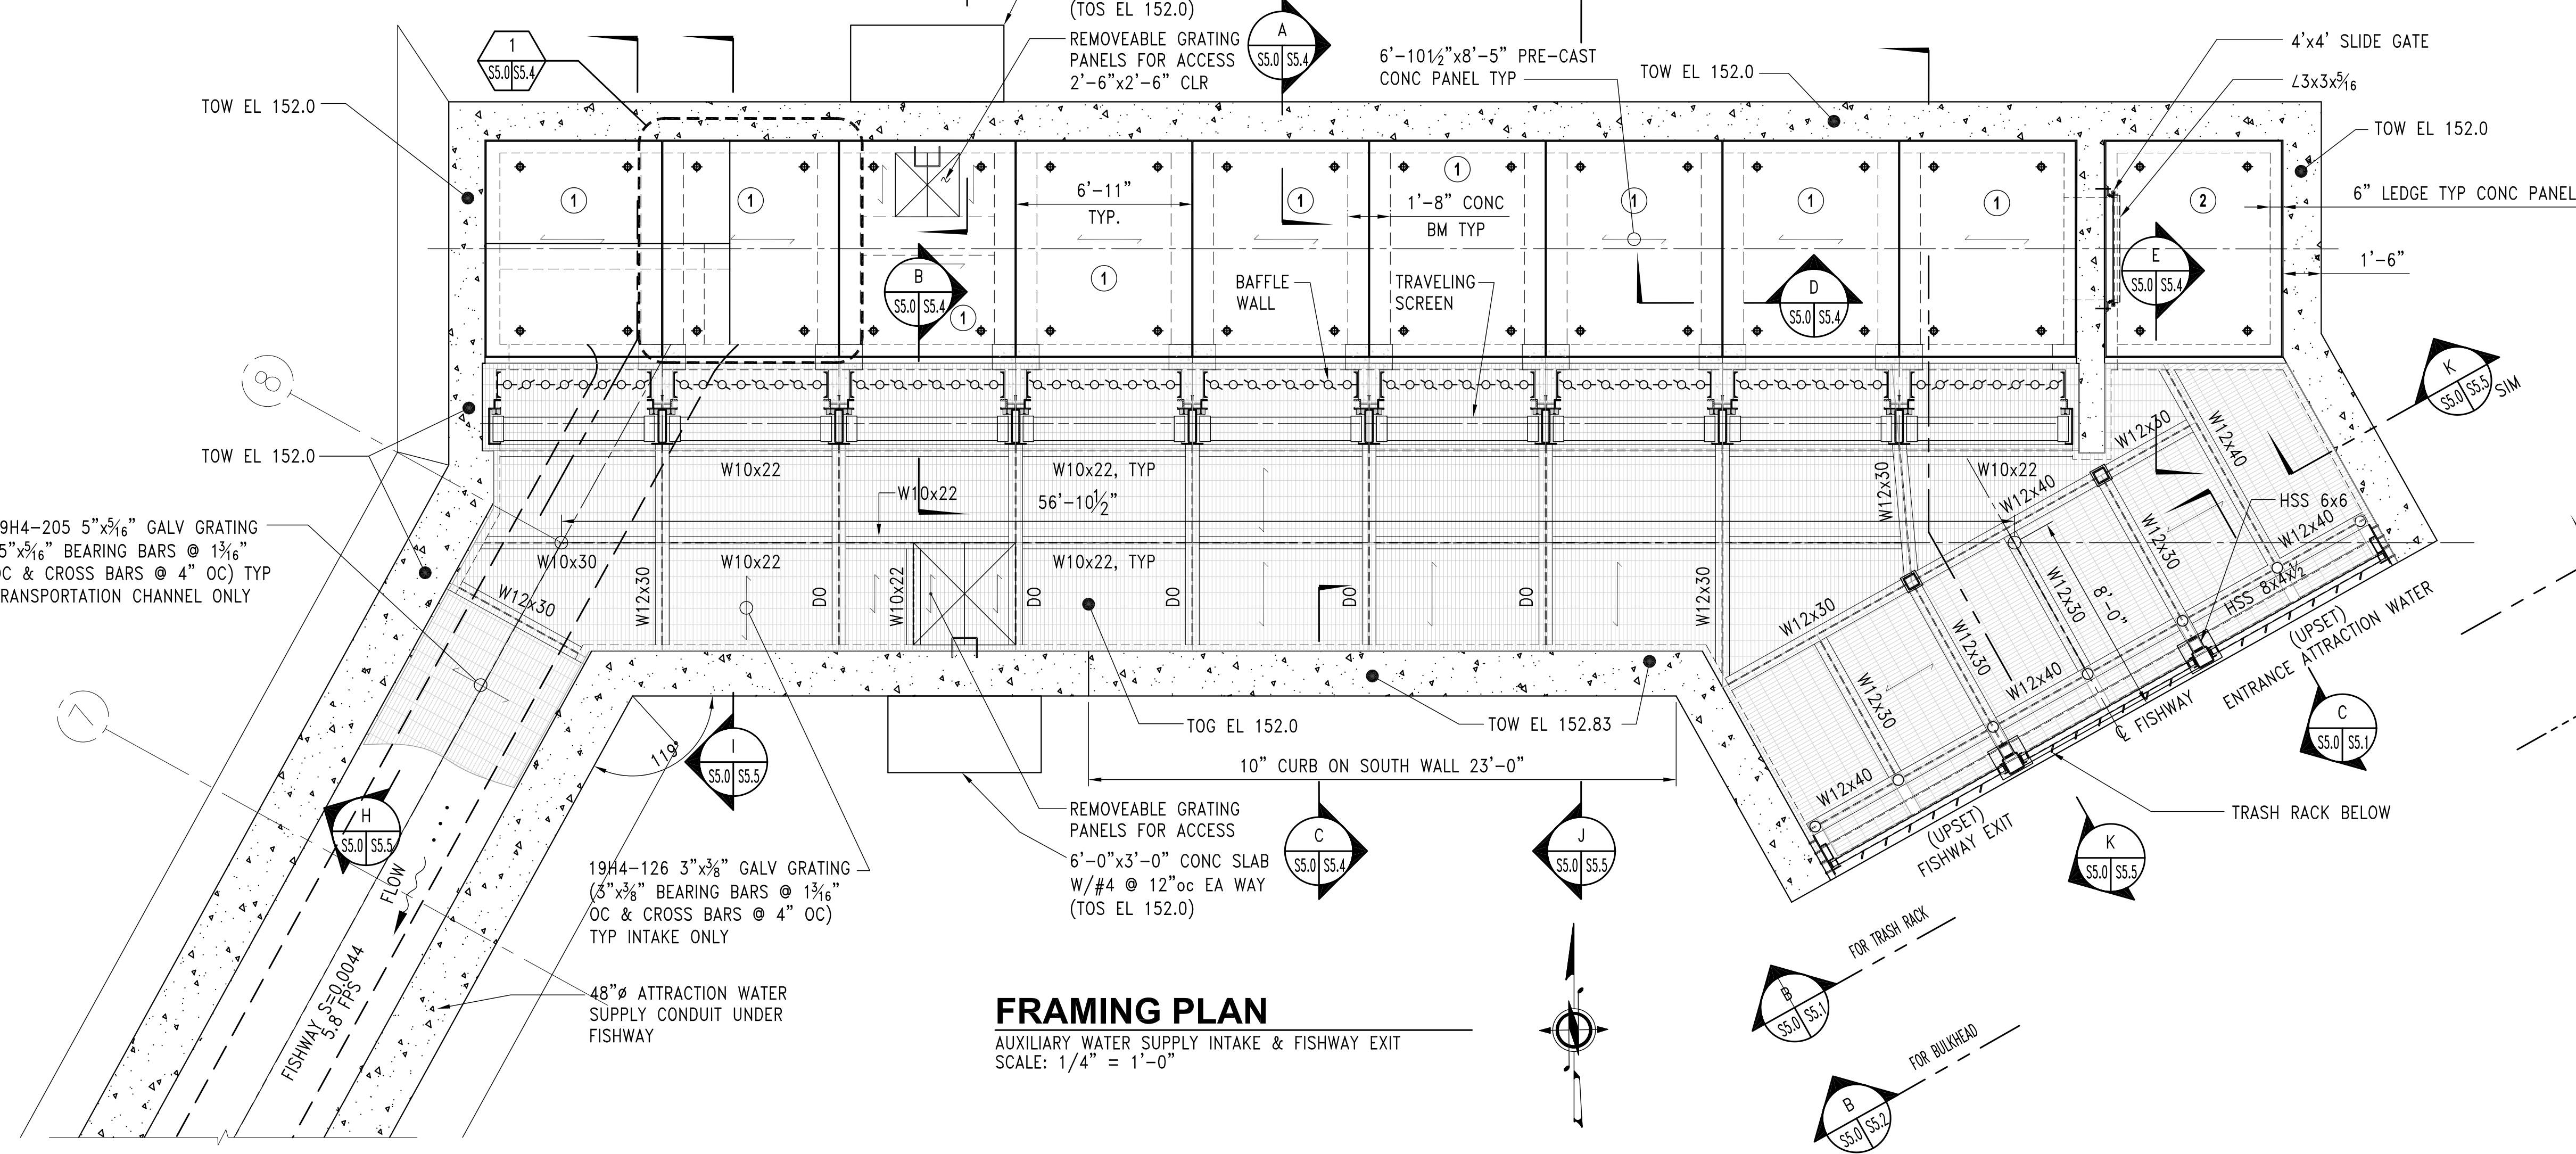

FRAMING PLAN
 AUXILIARY WATER SUPPLY INTAKE & FISHWAY EXIT
 SCALE: 1/4" = 1'-0"

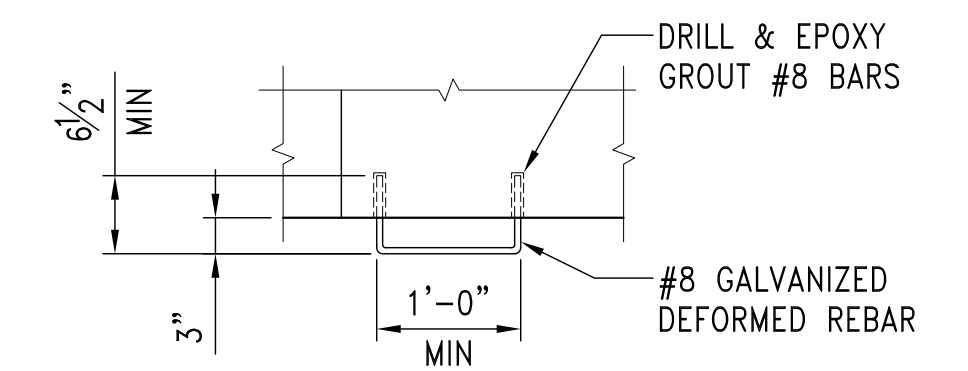

DETAIL
 SCALE: 3/4" = 1'-0"
 HANDHOLD

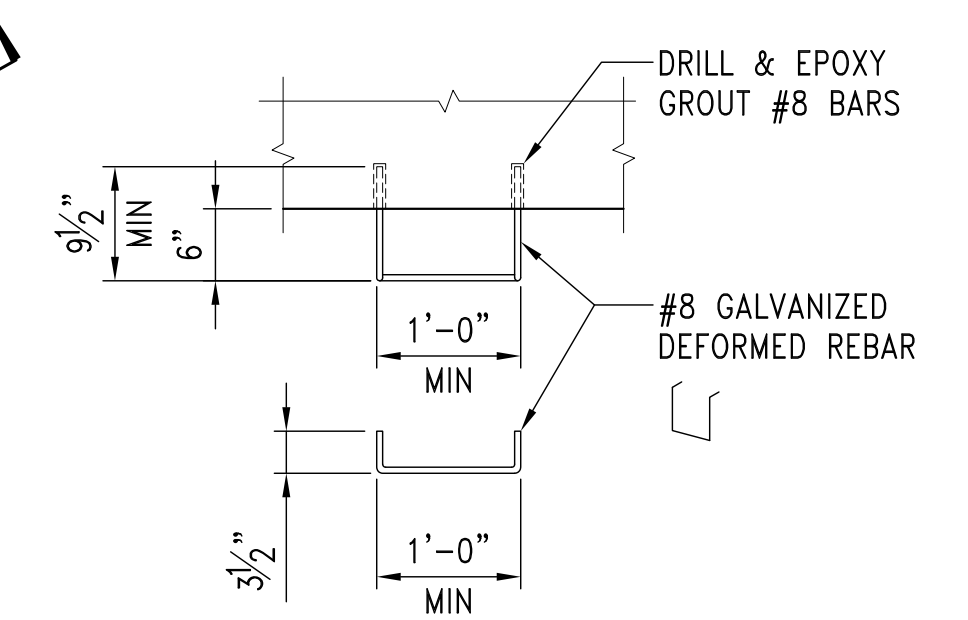

DETAIL
 SCALE: 3/4" = 1'-0"
 DROP RUNG STEP

